

FRONT ELEVATION 1/4" = 1'-0" 1

THESE DOCUMENTS ARE PROVIDED AS A CONSTRUCTION DOCUMENT TEMPLATE FOR THIS BUILDING TYPE. THESE DRAWINGS MUST BE REVIEWED AND ADAPTED BY A LICENSED ARCHITECT AND/OR ENGINEER TO MEET ALL STATE AND LOCAL JURISDICTIONAL REQUIREMENTS FOR THIS PROJECT. MODIFICATIONS THAT CHANGE THE IMAGE ELEMENTS OR KITCHEN OPERATIONS MUST BE APPROVED BY A TUMI BRANDS REGIONAL ARCHITECTURAL PARTNER (RAP) PRIOR TO CONSTRUCTION.

CONSULTANT'S SEAL

YYY-MM-DD  
PROGRESS SET

DATE	REMARKS

CONTRACT DATE: \_\_\_\_\_  
 BUILDING TYPE: END. MED 40  
 PLAN VERSION: MARCH 2021  
 BRAND DESIGNER: \_\_\_\_\_  
 SITE NUMBER: \_\_\_\_\_  
 STORE NUMBER: \_\_\_\_\_  
 PA/PM: \_\_\_\_\_  
 DRAWN BY.: \_\_\_\_\_  
 JOB NO.: IRV19-0275-00

ENDEAVOR 2.0


Enter address here



ENDEAVOR 2.0  
EXTERIOR  
ELEVATIONS

A4.0

PLOT DATE: 4/2/2021 9:58:30 AM

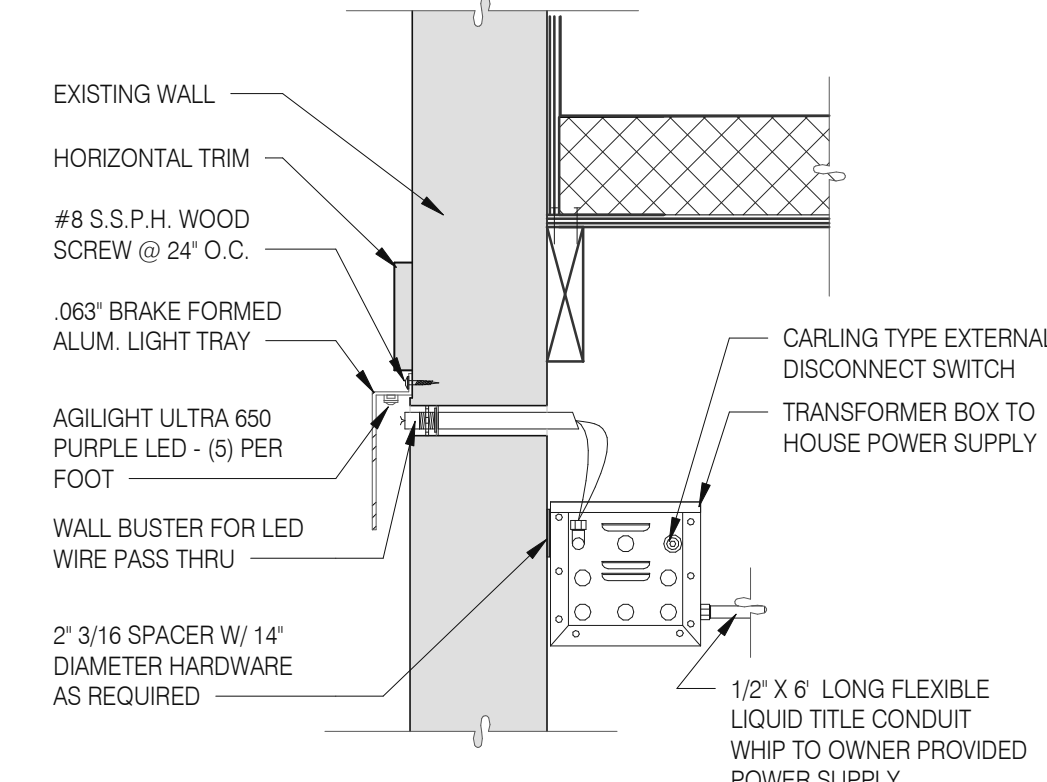

LED WALL WASHER DETAIL F

TYPE MARK	QTY	ITEM DESCRIPTION	LOC
TOWER			
V-09.14W	2	14" WHITE CHANNEL LETTERS VERTICAL	A4.1
SIDE ENTRY			
V-04.42	2	42" SWINGING BELL PURPLE LOGO FACE LIT	A4.1
V-200.EN	1	SIDE ENTRY AWNING 6' 4" X 6' 3" BLACK	A4.0
DRIVE THRU			
V-101.DT	1	DT AWNING (OVER DT) 9' 0" X 4' 0" BLACK	A4.1
EYEBROW AWNINGS			
V-202.EN	1	FRONT EYEBROW (WINDOW) 16' 7" X 6" H X 1' 4" D BLACK	A4.1
V-203.EN	1	DT EYEBROW (WINDOW) 7' 8" L X 6" H X 1' 4" D BLACK	A4.1
V-201.EN	1	SIDE ENTRY EYEBROW (WINDOW) 12' L 6" H X 1' 4" D BLACK	A4.0

SIGNAGE E

**MISCELLANEOUS**  
 A. SEE SHEET A1.1 "WINDOW TYPES" FOR WINDOW ELEVATIONS.

**SEALERS (REFER TO SPECS)**  
 A. SEALANT AT ALL WALL AND ROOF PENETRATIONS.  
 B. SEALANT AT ALL WINDOW AND DOOR FRAMES AND JAMB. DO NOT SEAL SILL @ WINDOWS.  
 C. APPLY NEOPRENE GASKET (CONT.) BETWEEN BUILDING AND CANOPY.

**CRITICAL DIMENSIONS**  
 A. REQUIRED CLEAR OPENING WIDTH TO ENSURE COORDINATION WITH STANDARD SIGNAGE/BUILDING ELEMENTS DIMENSIONS.

NOTE: NO EXTERIOR SIGNS ARE WITHIN THE SCOPE OF WORK COVERED BY THE BUILDING PERMIT APPLICATION. THE GENERAL CONTRACTOR SHALL BE RESPONSIBLE FOR COORDINATING THE INSTALLATION OF ALL EXTERIOR SIGNS AND INSTALLATION OF REQUIRED BLOCKING AND ELECTRICAL CONNECTIONS FOR FINAL APPROVED SIGNS.

GENERAL NOTES C

SYMBOL	NAME	FAMILY	FRAME OR MURAL	SIZE	LOCATION
G519	HIPNOTIZE ME BELL	D	M02	48x96	A4.0
G517	HIPNOTIZE ME BELL	D	M02	48x96	A4.0
G519	HIPNOTIZE ME BELL	D	M02	48x96	A4.1
G517	HIPNOTIZE ME BELL	D	M02	48x96	A4.1

**PAINTING**  
 APPLICATOR MUST DO THEIR DUE DILIGENCE WITH PREPARATION.  
 PRIMER: 1 COAT SW A24W8300  
 FINISH: 2 COATS SW A82-100 SERIES, MATCH COLORS FROM MATERIAL SCHEDULE.  
 A-100 EXTERIOR LATEX SATIN.

PAINT NOTES A

SYMBOL	ITEM/MATERIAL	MANUFACTURER	MATERIAL SPEC	COLOR	CONTACT INFORMATION
1	SIDING	JAMES HARDIE	ARTISAN V-GROOVE 144"L X 8.25"W; 7" EXPOSURE COMES PRIMED FOR PAINT	WORLDLY GRAY (SW7043), SEMI-GLOSS	SEE C / A 7.2
2	SCUPPERS	-	-	WORLDLY GRAY (SW7043), SEMI-GLOSS	
3	DOWN SPOUTS	-	-	WORLDLY GRAY (SW7043), SEMI-GLOSS	
4	HARDIE TRIM	JAMES HARDIE	HARDIE TRIM 5/4 SMOOTH 1"x5.5"	CYBERSPACE (SW7076), SEMI-GLOSS	SEE C / A 7.2
5	HARDIE REVEAL PANEL	JAMES HARDIE	REVEAL PANEL SYSTEM	CYBERSPACE (SW7076), SEMI-GLOSS	SEE C / A 7.2
6	HOLLOW METAL DOOR	-	-	SW PURPLE TB2603C, SEMI-GLOSS	
7	AWNINGS	SIGNAGE VENDOR	-	BLACK BY THE SIGNAGE VENDOR	
8	CORNER TOWER	WESTERN STATE	T-GROOVE 24GA PAINTED 18" PANEL	WEATHERED RUSTIC	SEE C / A 7.2
9	RECESS OF SIDE ENTRY PORTAL	WESTERN STATE	T-GROOVE 24GA PAINTED 18" PANEL	WEATHERED RUSTIC	SEE C / A 7.2
10	HARDIE REVEAL PANEL	JAMES HARDIE	REVEAL PANEL SYSTEM	SW PURPLE TB2603C, SEMI-GLOSS	SEE C / A 7.2
11	METAL PARAPET CAP	-	24GA GALVANIZED	CYBERSPACE (SW7076) KYNAR 500 COATING	

EXTERIOR FINISH SCHEDULE D

- 329 MECHANICAL UNIT, SEE ROOF PLAN.
- 401 BUILDING SIGN BY VENDOR. REQUIRES ELECTRICAL, SEE ELECTRICAL PLANS.
- 407 METAL CANOPIES BY VENDOR. REQUIRES ELECTRICAL, SEE ELECTRICAL PLANS.
- 408 CO2 FILLER VALVE & COVER.
- 416 HOSE BIB BOX AT 18" A.F.F.
- 419 EXTERIOR LIGHT FIXTURE, SEE ELECTRICAL DRAWINGS.
- 422 PURPLE LIGHT WALL WASHER, PROVIDED BY SIGNAGE VENDOR.
- 424 LINE OF ROOF BEYOND.

KEY NOTES B

